


COPYRIGHT © 2000 EMCON
 ALL RIGHTS RESERVED. NO PART OF THIS PUBLICATION MAY BE REPRODUCED OR TRANSMITTED IN ANY FORM OR BY ANY MEANS, ELECTRONIC OR MECHANICAL, INCLUDING PHOTOCOPYING, RECORDING OR OTHERWISE, WITHOUT THE PERMISSION IN WRITING FROM EMCON.

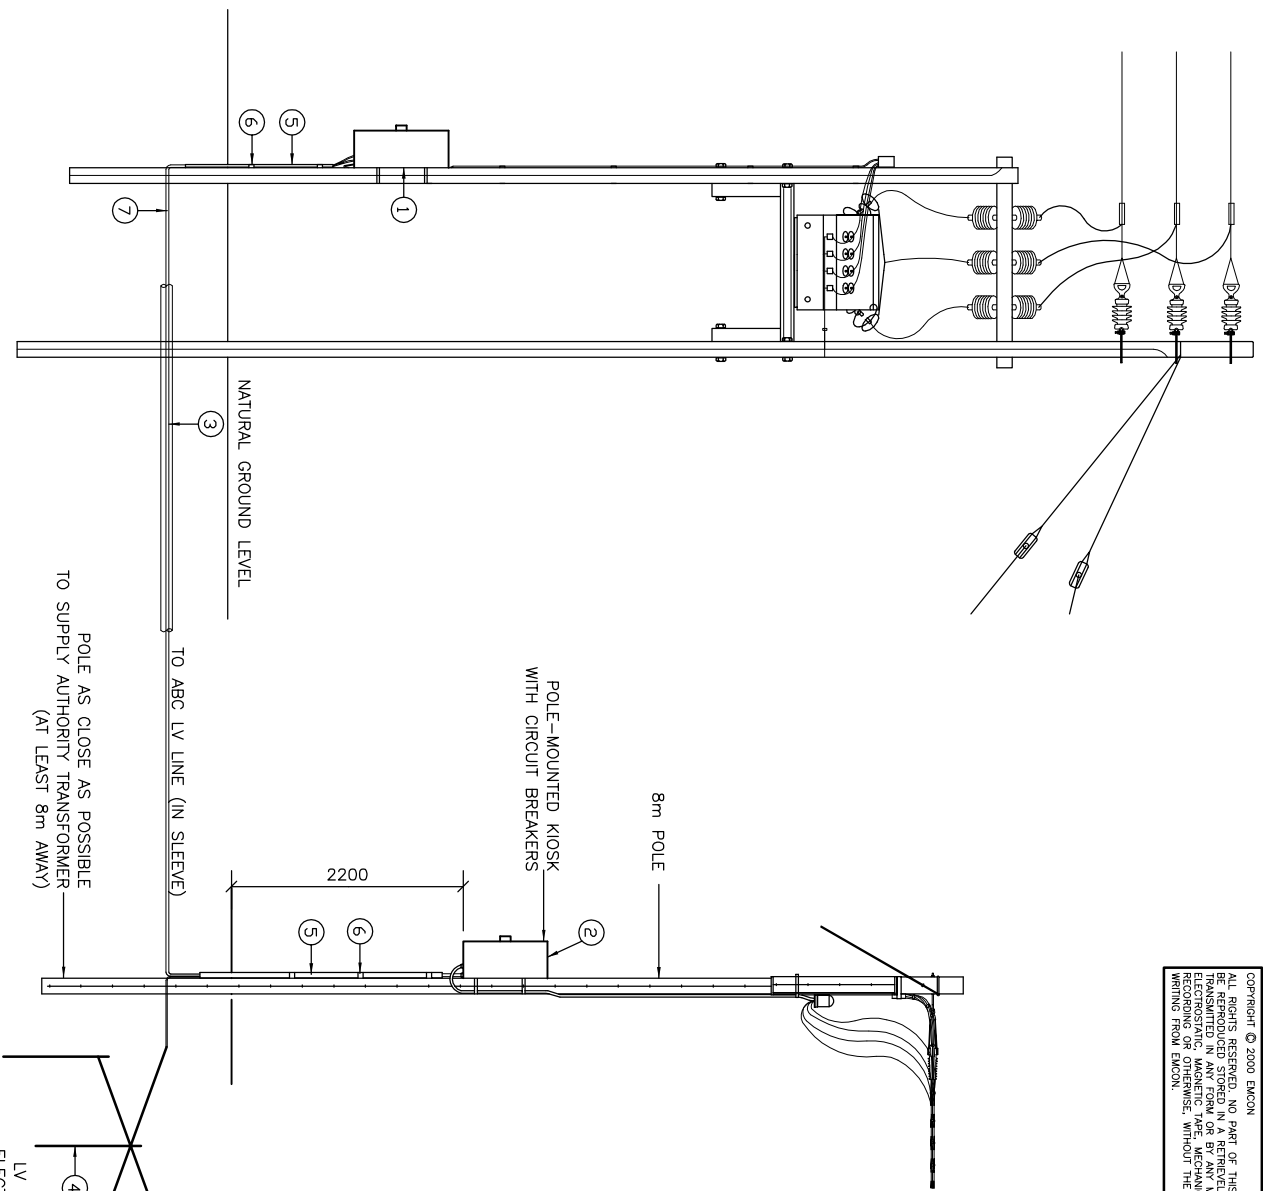

S.A DISTRIBUTION TRANSFORMER

ITEM	DESCRIPTION	QTY	REMARKS
1	POLE MOUNTED METER BOARD	1	SEE DWG. STD-LVABC-20
2	POLE MOUNTED KIOSK	1	SIZE AS SPECIFIED
3	SUPPLY TO CONSUMER	4	1.2m LONG, 16mm ϕ
4	EARTH SPIKE	4	50mm ϕ HDPE
5	KICK PIPE	2	
6	GALV. SADDLES	2	
7	KIOSK EARTH CONDUCTOR	14m	70mm ² BARE CU CONDUCTOR

NOTES:
 1. LV EARTHING CONDUCTOR OF KIOSK TO BE INSTALLED IN TRENCH FOR 1m AND TERMINATED AT A THREE-POINT STAR EARTH.

ELECTRICAL & MECHANICAL CONSULTING ENGINEERS



Emcom
 CONSULTING GROUP
 POWER PLANNING UNIT



Box 1900 Square Park Tel: (061) 224725
 Windhoek Hebenstreit Street Fax: (061) 233207
 NAMIBA Ludwigsdorf E-mail: ont@emcom.com, no

DRAWING TITLE
**LOW VOLTAGE AERIAL BUNDLED CONDUCTOR
 DISTRIBUTION: DISTRIBUTION KIOSK
 CONNECTION,
 SUPPLY AUTHORITY TRANSFORMER**

DESIGNED: A.K	DRAWN: J.W.S	REV: 01-2001
DRAWING No: STD-LVABC-02	SCALE: N.T.S	

ERROR: syntaxerror
OFFENDING COMMAND: --nostringval--

STACK:

/Title
()
/Subject
(D:20100127111714+02'00')
/ModDate
()
/Keywords
(PDFCreator Version 0.9.5)
/Creator
(D:20100127111714+02'00')
/CreationDate
(johnny)
/Author
-mark-